


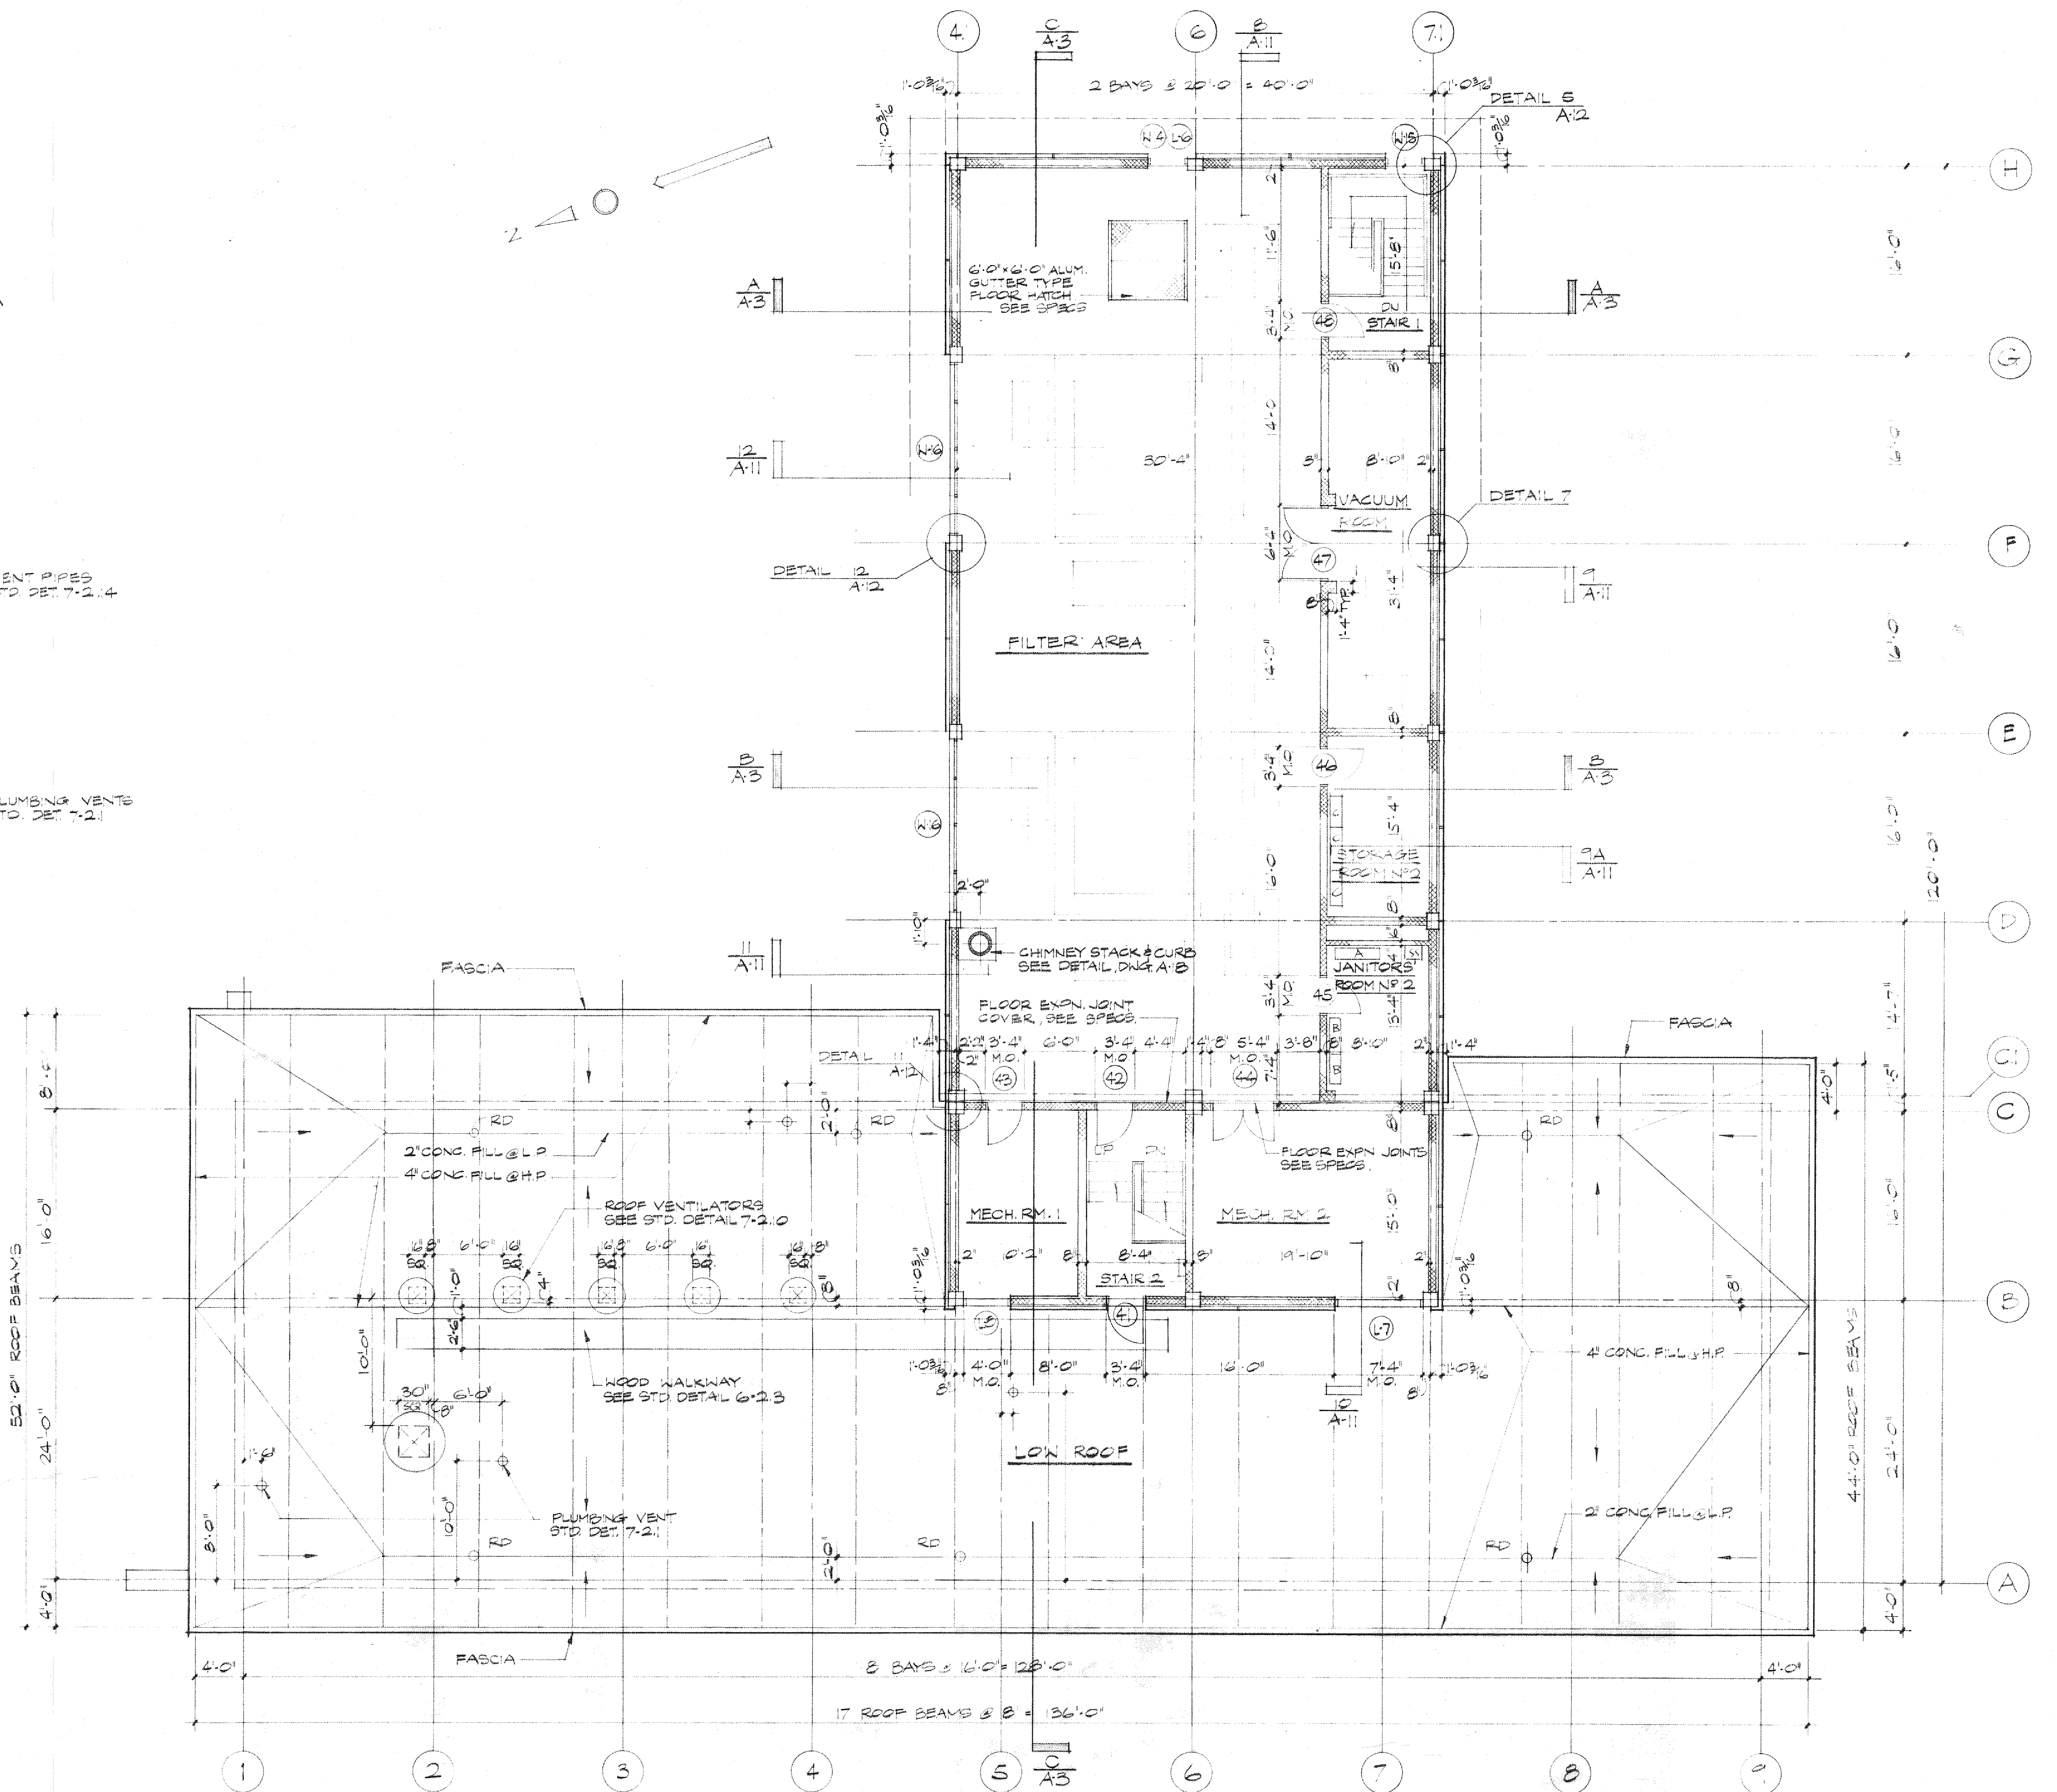

2ND FLOOR PLAN






TOWN OF BURRILLVILLE, RHODE ISLAND
BOARD OF SEWER COMMISSIONERS
WASTEWATER TREATMENT FACILITIES
OPERATIONS BUILDING
PLANS II
ARCHITECTURAL

JOB 4868

FILE NO. H-68970-1

SHEET A-2

					DRAWN BY MSchwartz
					DEPT. CHECK D Dixon
					PROJ. CHECK K J Marshall
NUMBER	DATE	MADE BY	CHECKED BY		DESCRIPTION
REVISIONS					

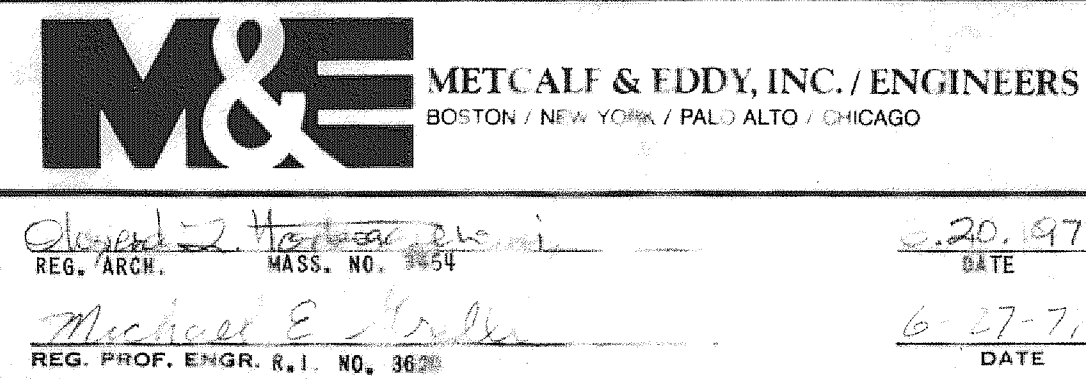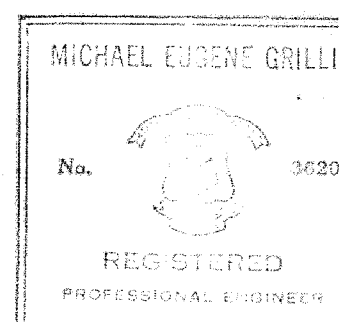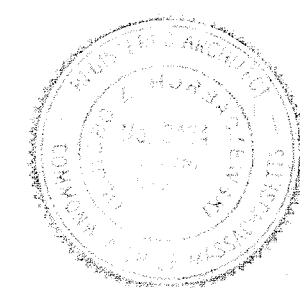

SCALE:

$\frac{1}{8} = .125$

UNLESS OTHERWISE NOTED OR CHANGED, BY REPRODUCTION