



BASEMENT PLAN

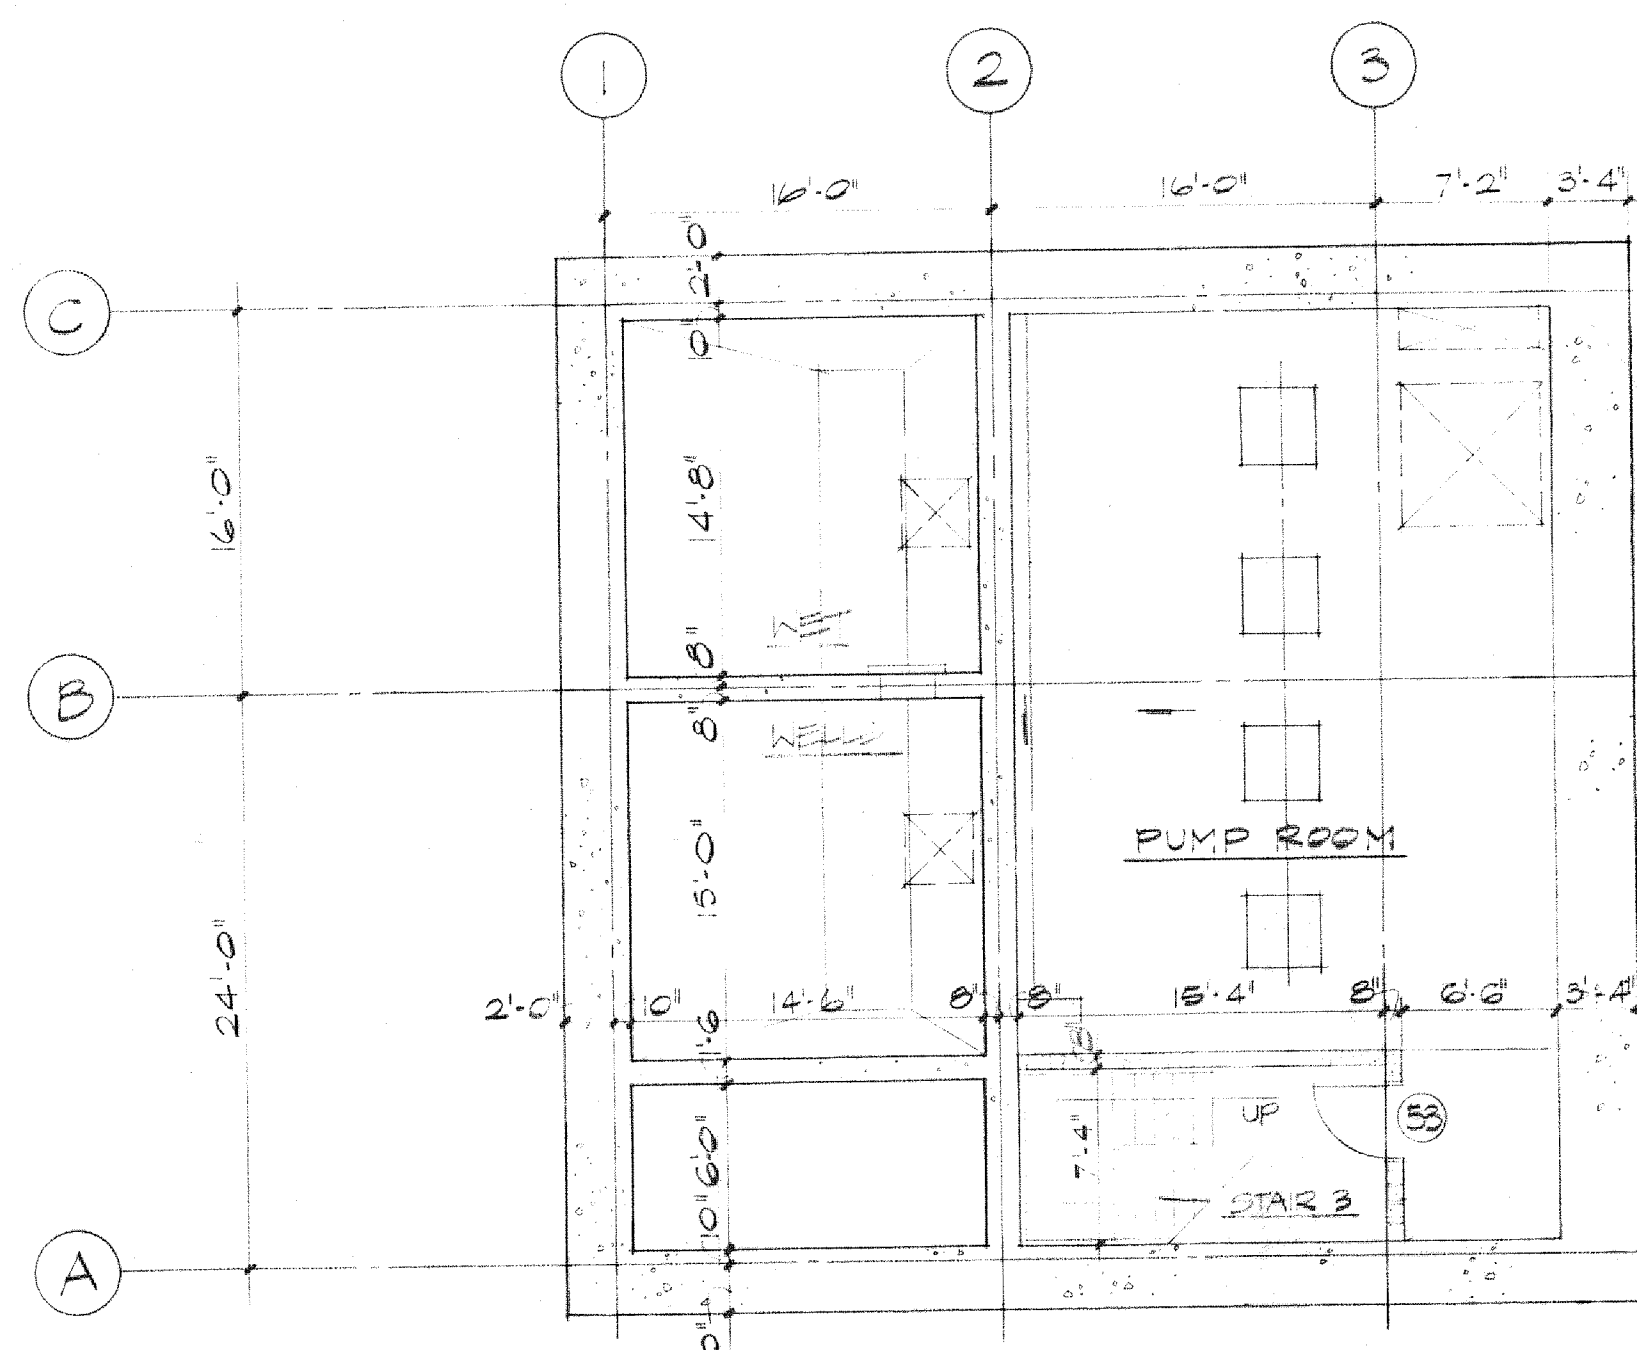



SUB-BASEMENT PLAN

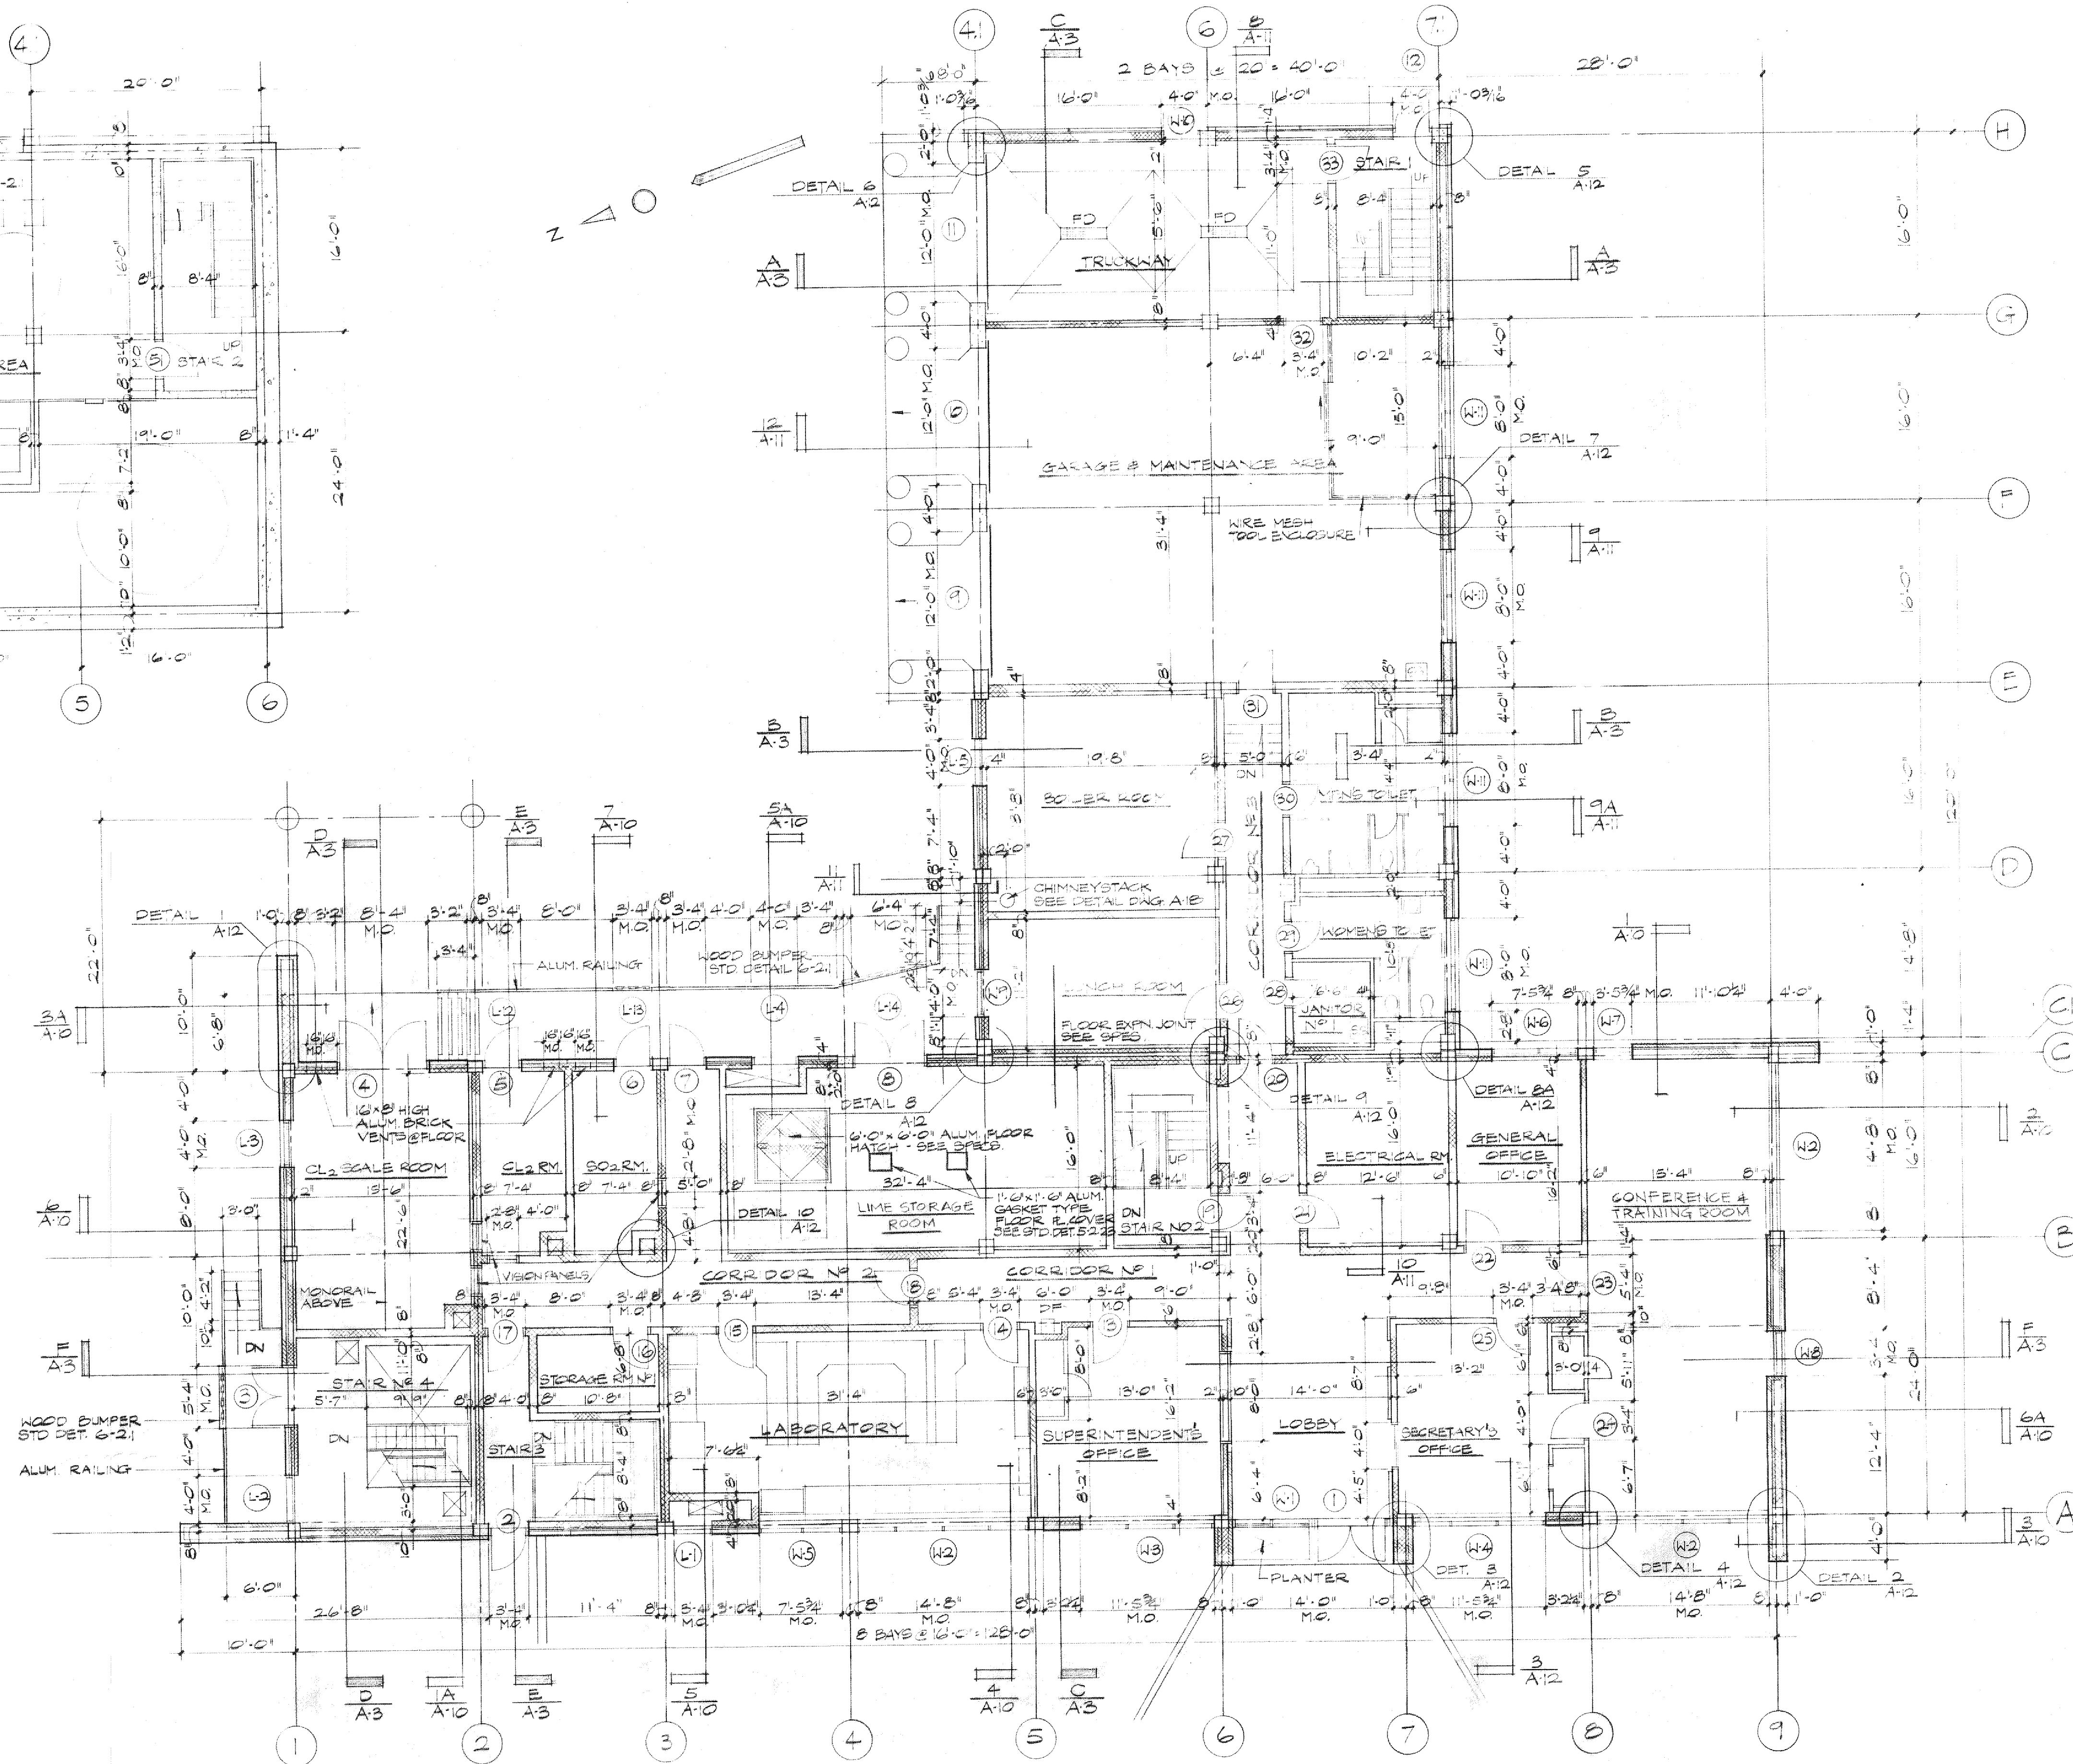

1ST FLOOR PLAN

RECORD DRAWING

						DRAWN BY M. Sullivan
						DEPT. CHECK M. Sullivan
						PROJ. CHECK J. Marshall
NUMBER	DATE	MADE BY	CHECKED BY	DESCRIPTION		
				REVISIONS		

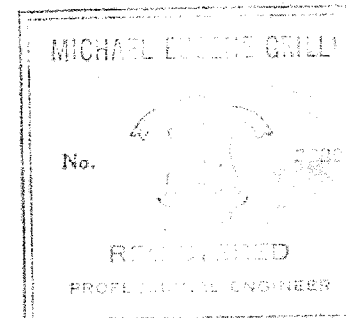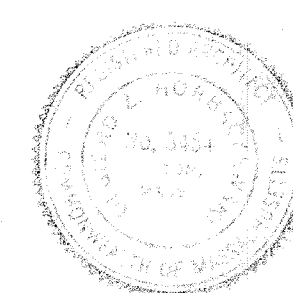

M&E METCALF & EDDY, INC. / ENGINEERS
 BOSTON / NEW YORK / PALM BEACH / CHICAGO

REG. ARCH. 6-20-1917
 REG. PROF. ENGR. 6-2-77

SCALE: 1/8" = 1'-0"

UNLESS OTHERWISE NOTED OR CHANGED BY REPRODUCTION

TOWN OF BURRILLVILLE, RHODE ISLAND
 BOARD OF SEWER COMMISSIONERS

WASTEWATER TREATMENT FACILITIES

OPERATIONS BUILDING
 PLANS I
 ARCHITECTURAL

JOB: 4868

FILE NO.: 4-68969-1

SHEET: 4-1